

#: 444

DATE: 10/10

RESIDENCE FOR MR. AND MRS. APPLIGATE  
1234ANYWHERE LANE JUPITER FLA.

STEPHEN SANDERS  
DESIGNER-DRAFTER





#:

REV:


FLOOR PLAN

NEIT

ADR-220

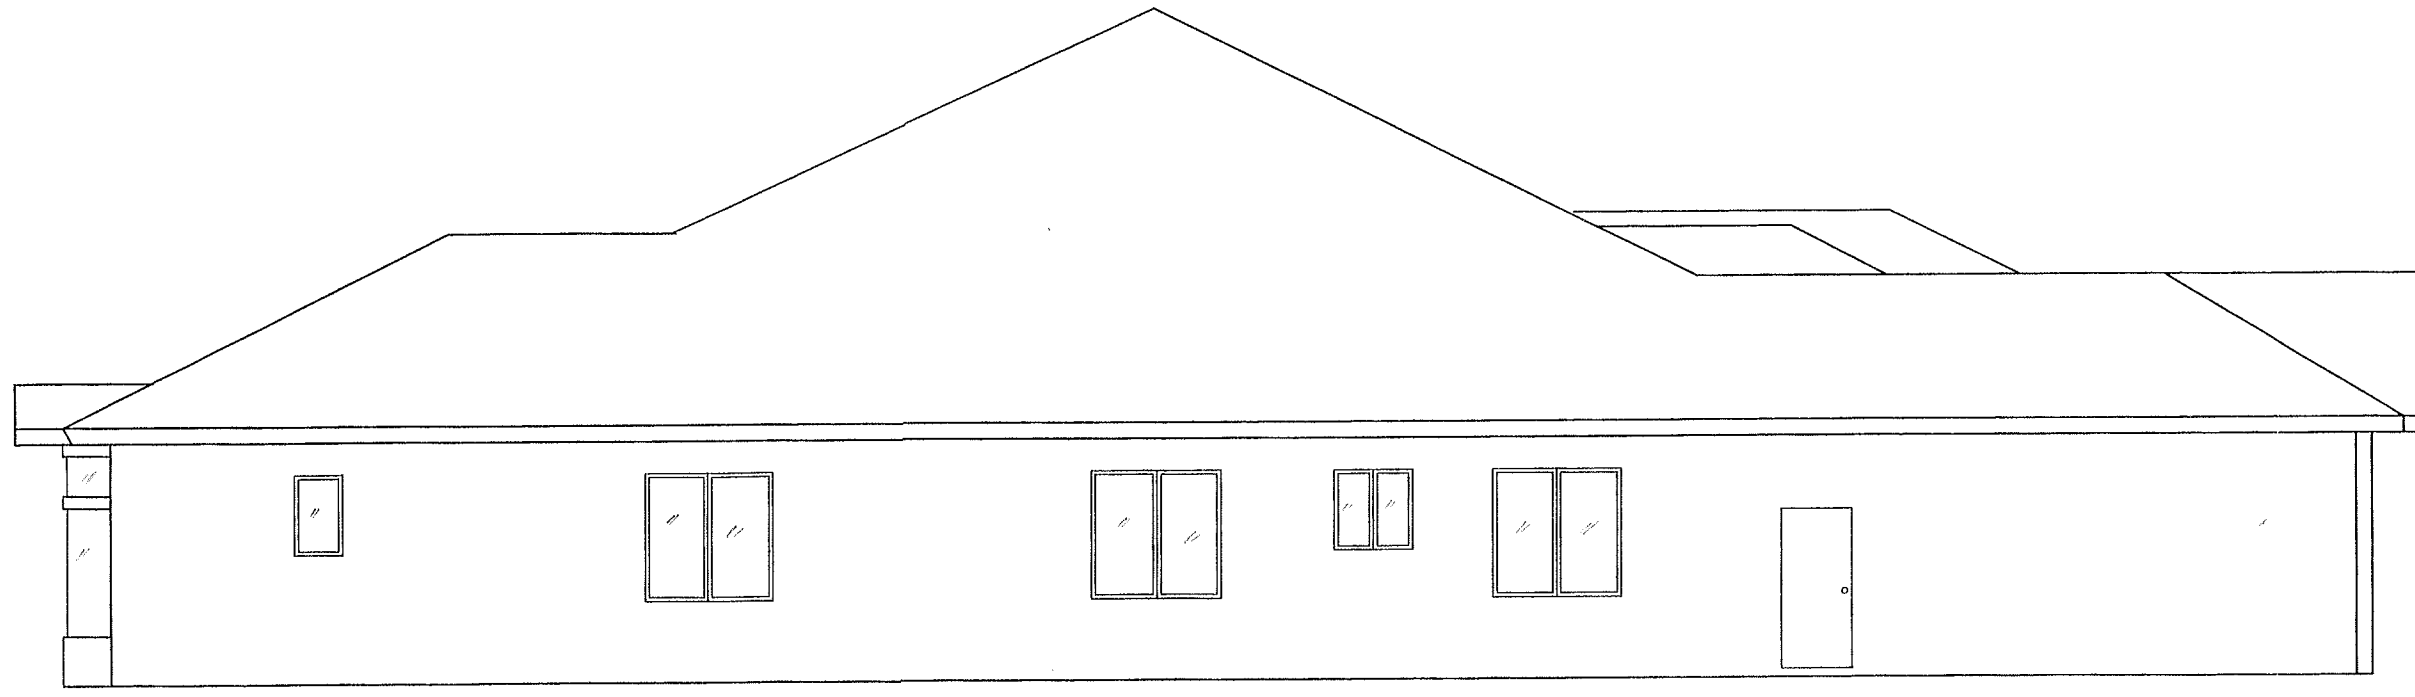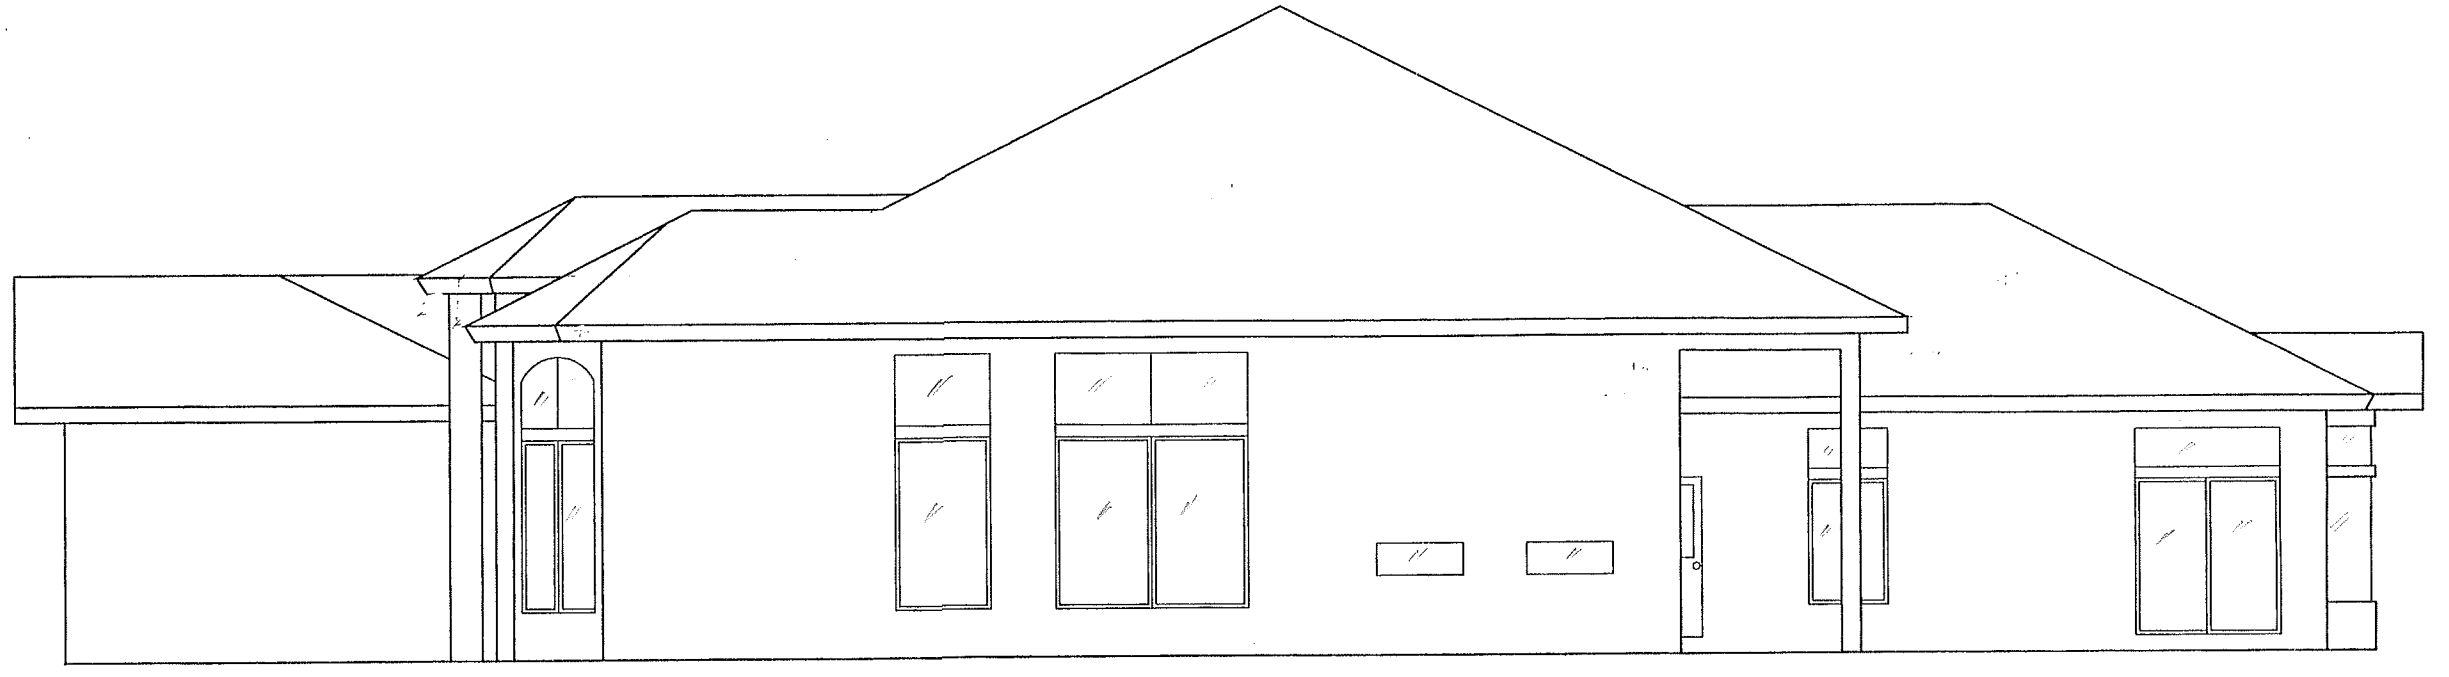


<p>PROJECT #:</p>	<p>DATE:</p>	<p>RESIDENCE FOR MR. AND MRS. APPELEGATE 1234 ANYWHERE LANE JUPITER FLA.</p>	<p>STEPHEN SANDERS DESIGNER-DRAFTER</p>	
<p>SHEET #:</p>	<p>REV:</p>	<p>FLOORPLAN</p>	<p>NEIT ADR-220</p>	

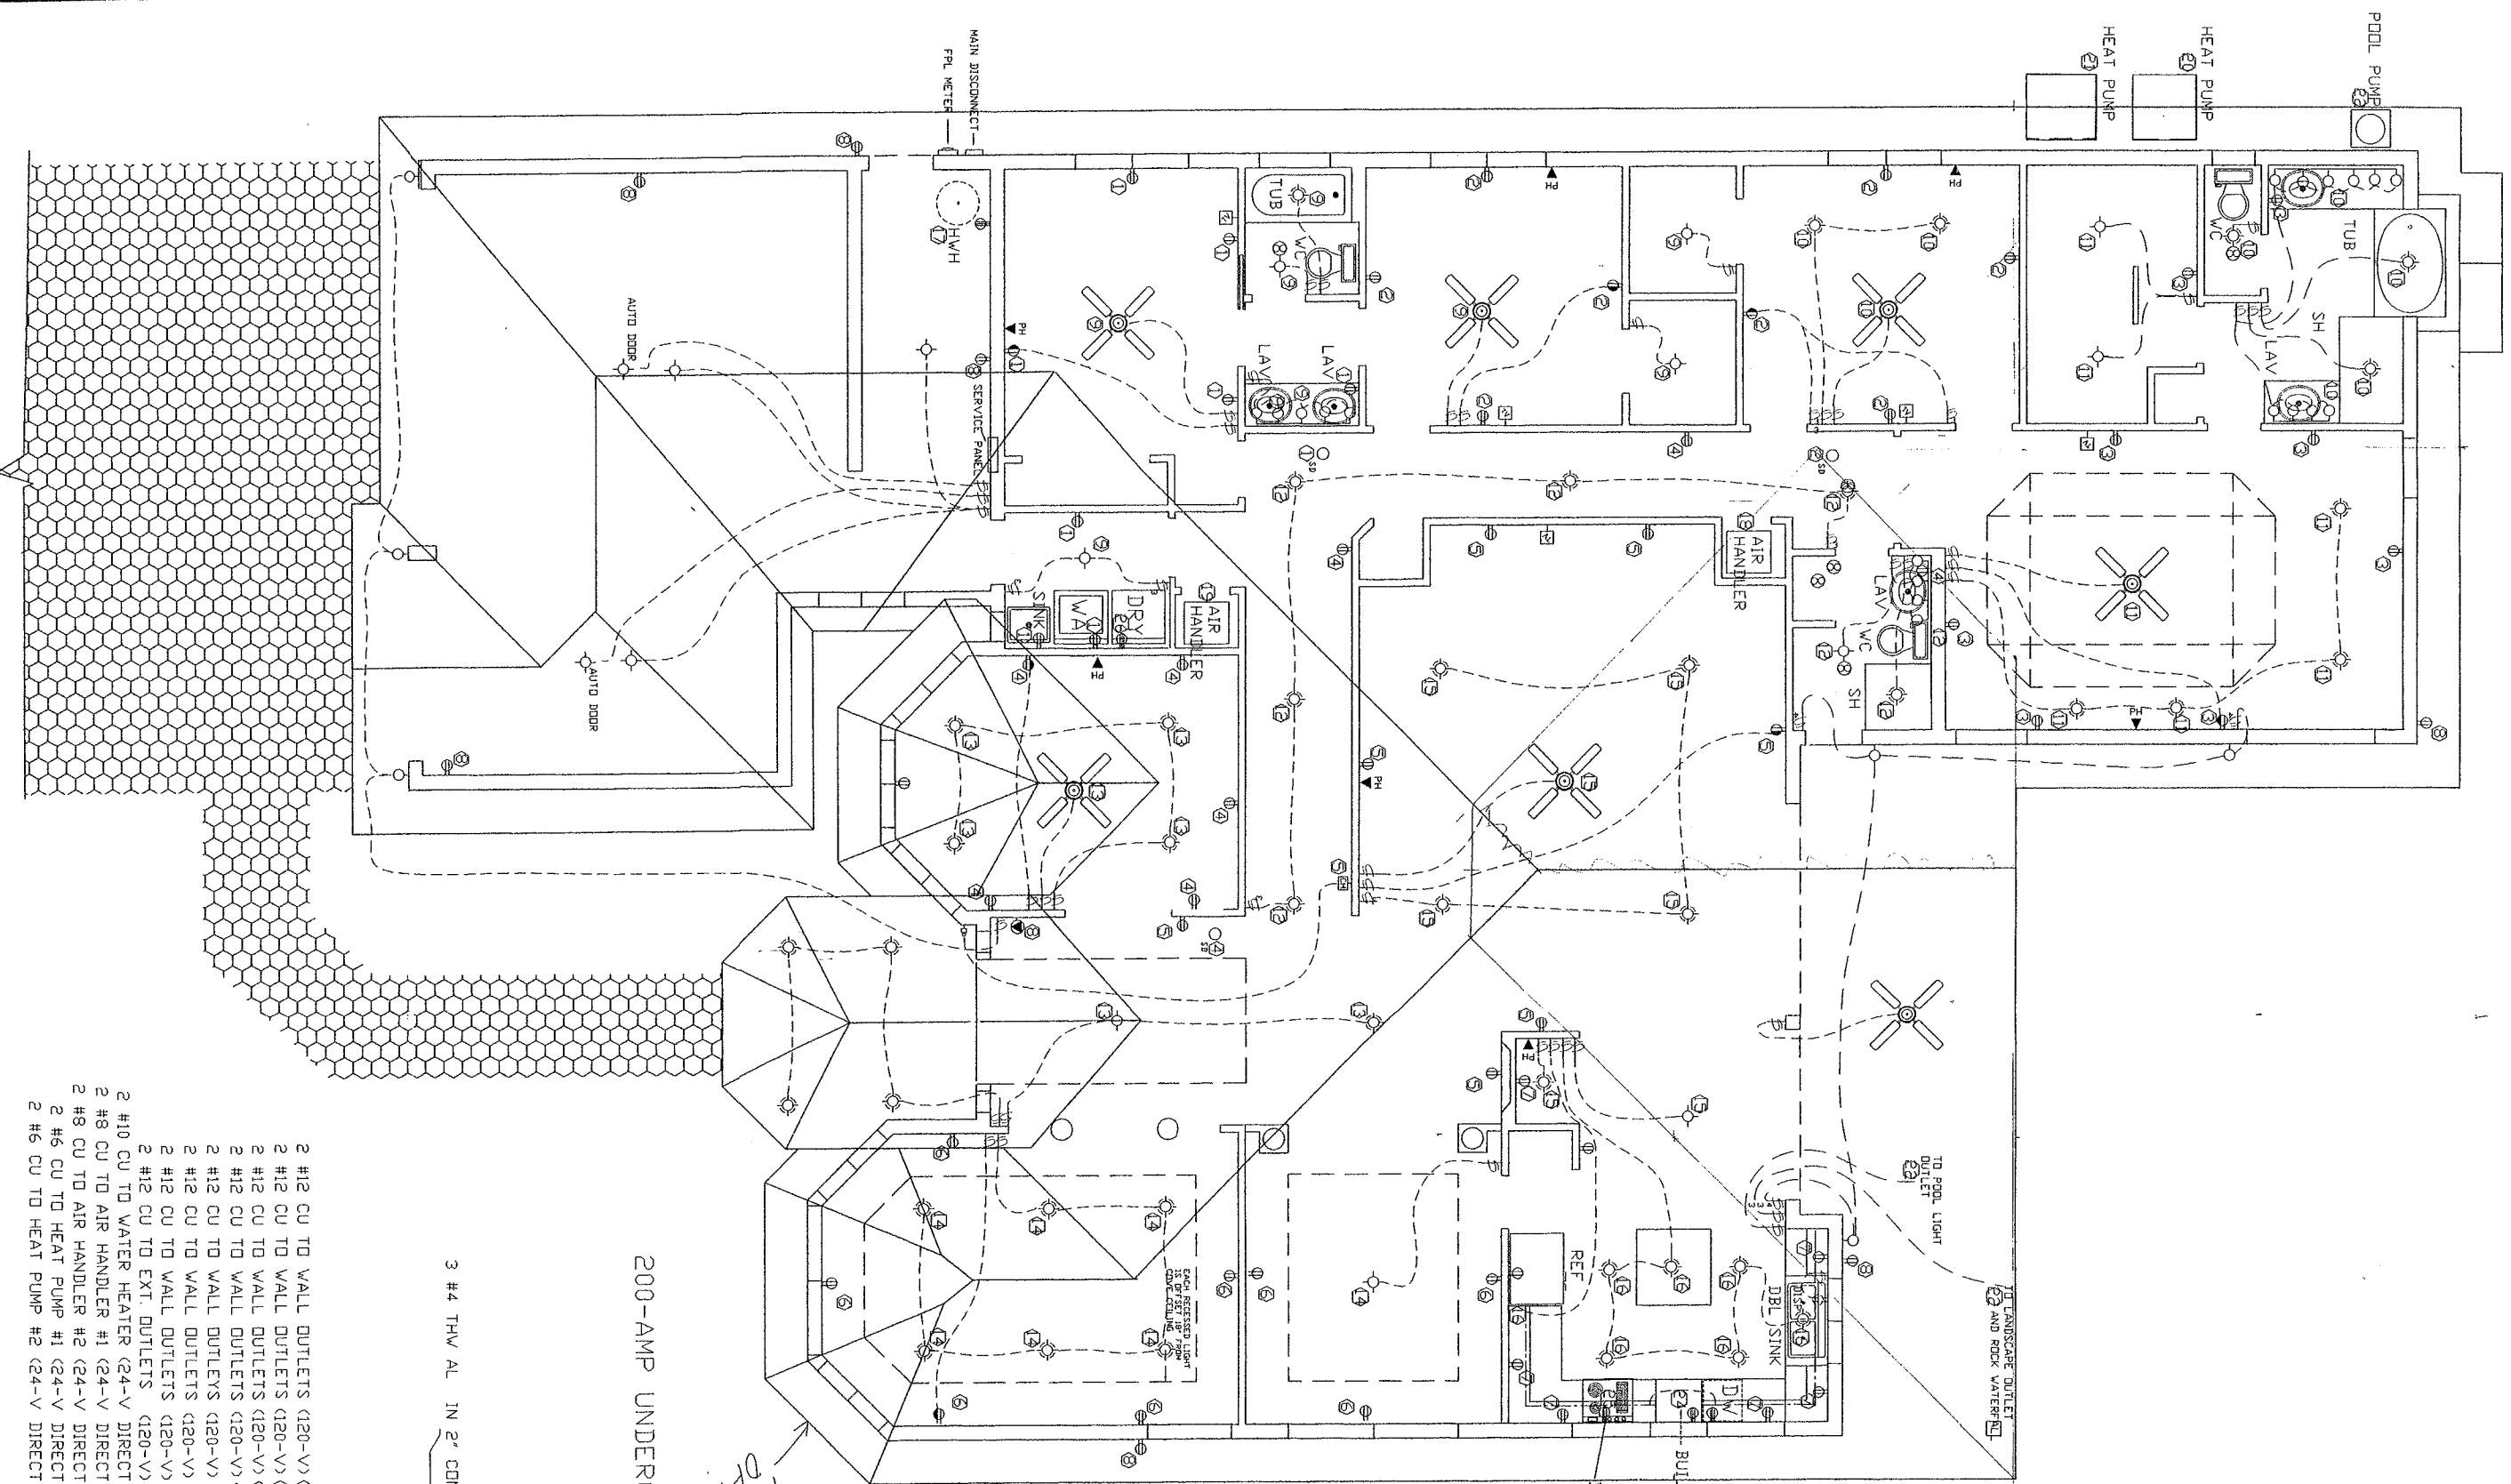

- CONSTRUCTION NOTES**
- 1 ONLY UL LISTED MATERIALS BE USED IN ELECTRICAL WIRING
  - 2 ALL SUCH WIRING SHALL BE IN ACCORDANCE WITH NEC
- ELECTRICAL AND OTHER SYMBOLS**
- ALARM SYSTEM
  - ⊠ TV OUTLET
  - ⊕ CEILING OUTLET
  - WALL OUTLET
  - RECESSED CEILING OUTLET
  - 120 VOLT OUTLET
  - 120 V OUTLET TO SWITC
  - 240 VOLT OUTLET
  - SWITCH
  - 3 WAY SWITCH
  - PHONE OUTLET
  - SD SMOKE DETECTOR
  - CIRCUIT
  - EXHAUST FAN

**200-AMP UNDERGROUND ELECTRIC SERV**


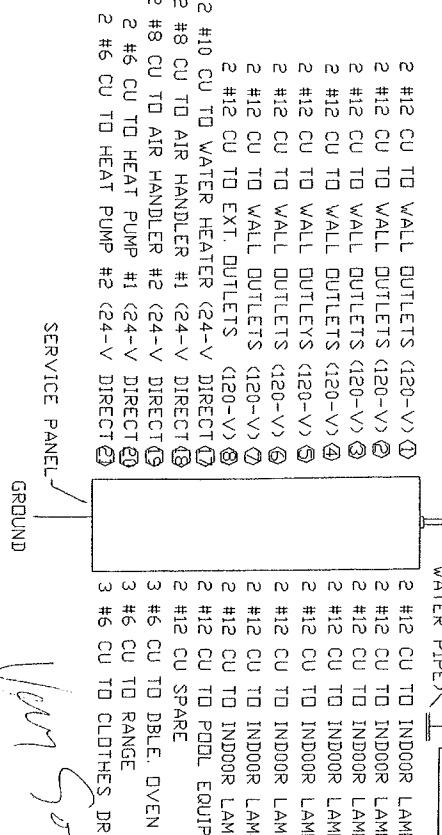


*View Set*

ID & QUANT.	COMMON NAME	BOTANICAL NAME	HEIGHT	REMARKS
5	FLA. THATCH PALM	THRINAX RADICATA	36 FEET	PALM
15	WILD COFFEE	PSYCHOTRIA NERVOSA	8 FEET	WHITE FLOWERING
5	BONITA	BONITA DAPHNIDES	30 FEET	YELLOW FLOWERING
38	GOPHER APPLE	LICANIA MICHAUXII	12 INCH	WHITE FLOWERING
34	SWORD FERN	NEPHROLEPIS EXALTA	12 INCH	PERIMETER FERN
E	GRASS			

### PLANT INDEX

SYMBOLS	DESCRIPTION
---	PROPERTY LINE
---	SETBACK LINE
---	EASEMENT LINE
---	ELECTRICAL LINE
---	TELEPHONE LINE
---	CABLE T V LINE
---	WATER LINE
---	SEWER LINE
---	STREET LIGHT FIXTURE

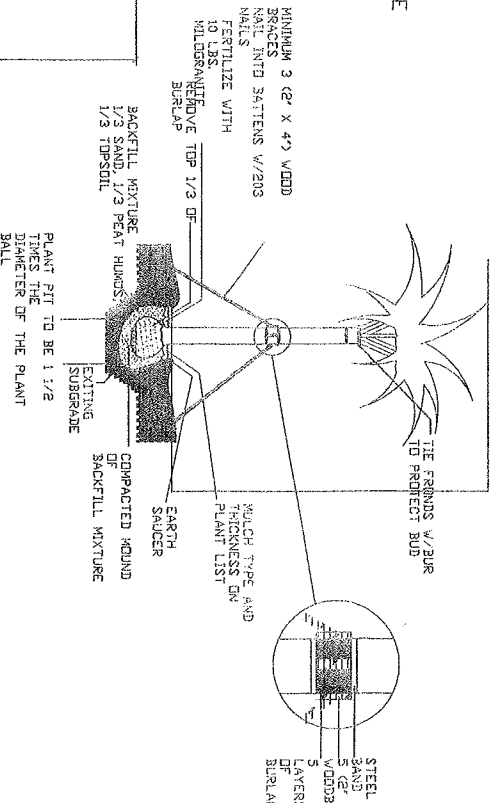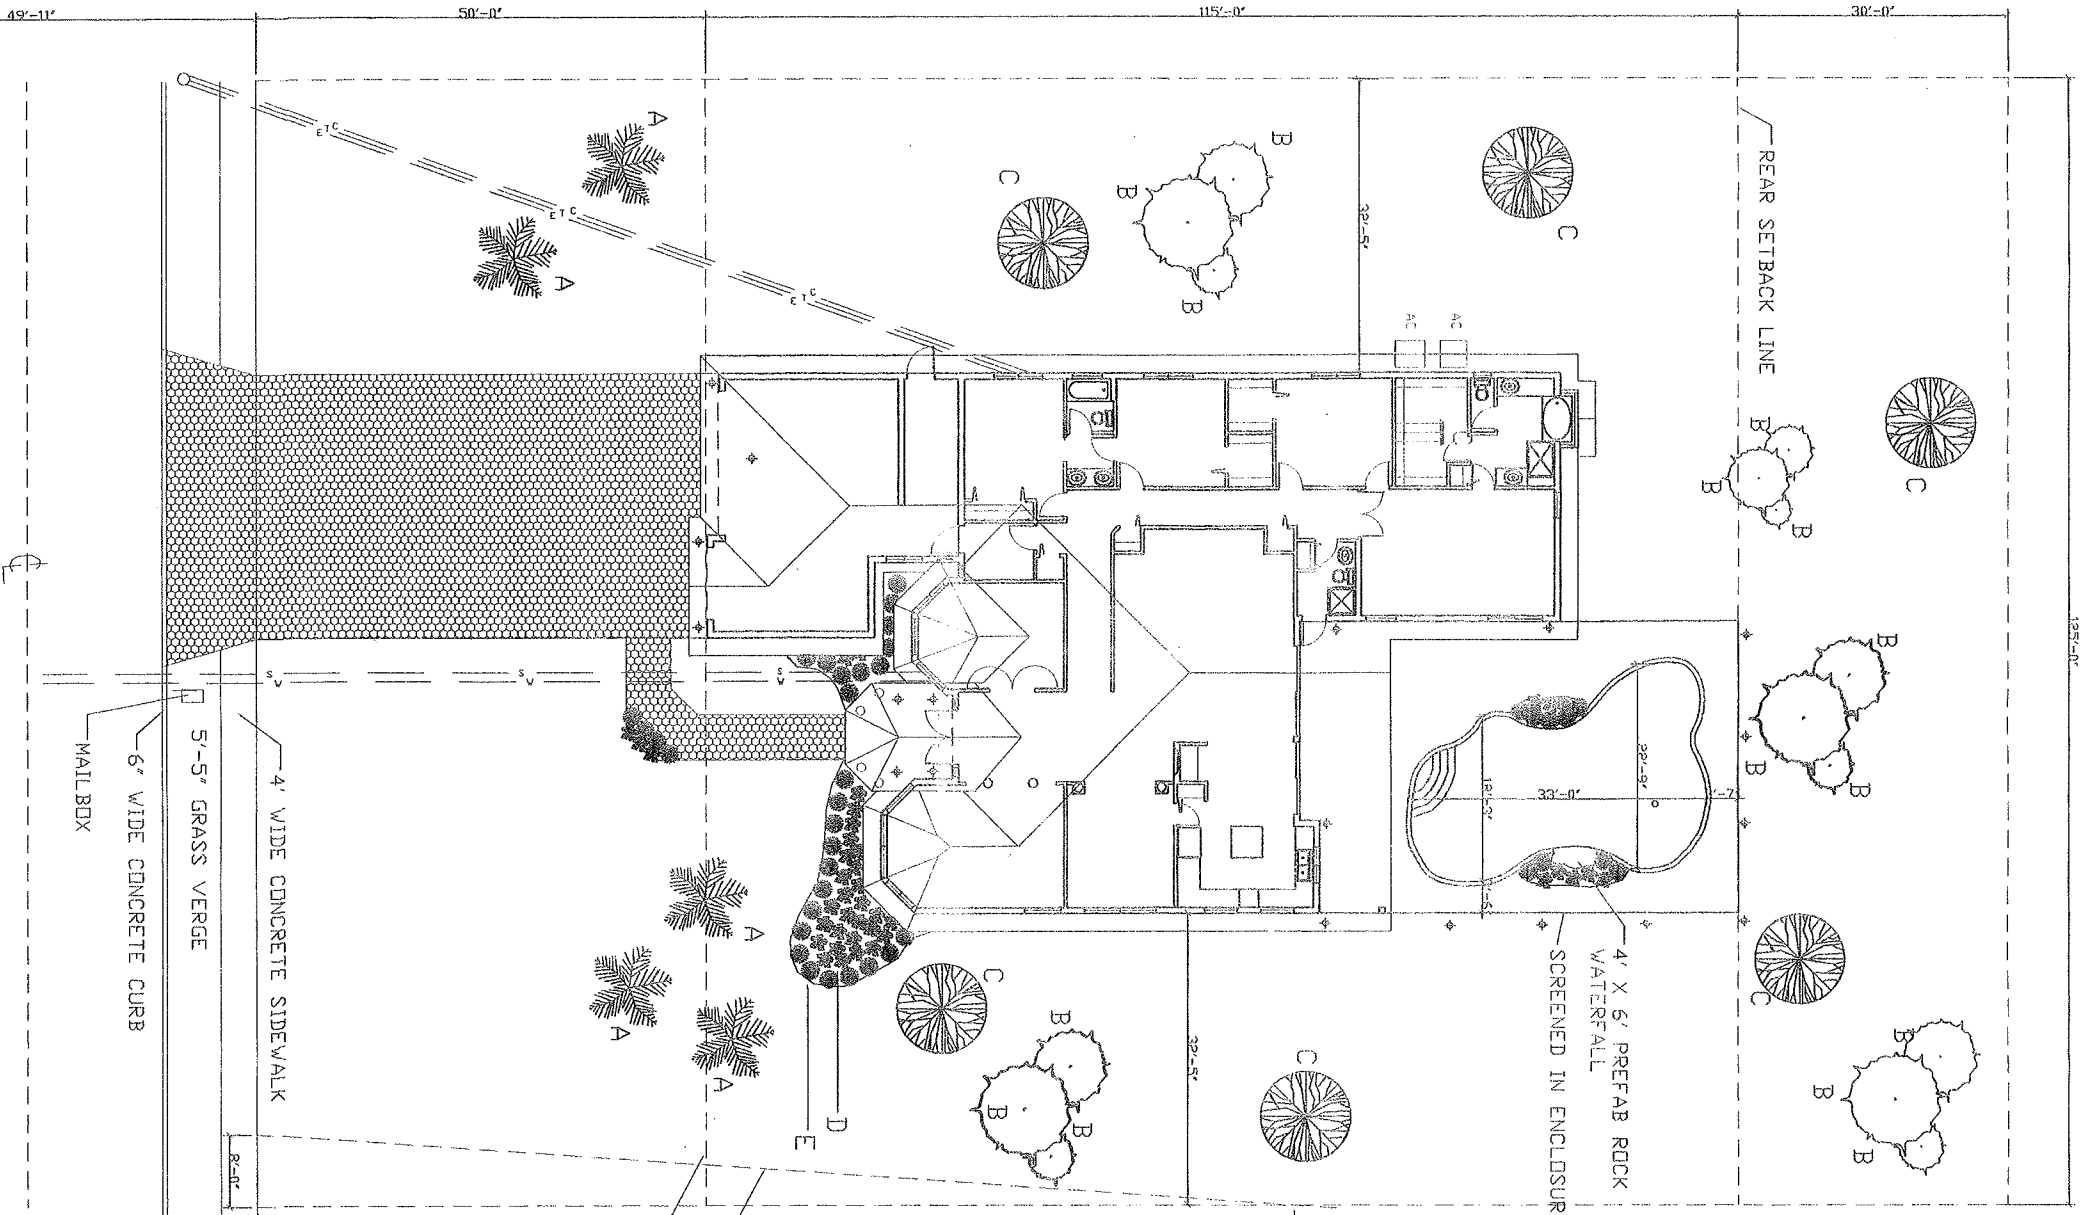

# PLOT PLAN

SCALE 3/32" = 1'-0"

WINDCREST DRIVE

BRIDGET DR.

SHEET: A  
 JOB NUMBER:  
 INSTRUCTOR:  
 DATE: 04/18/18  
 DRAWN BY: SA  
 ADR  
 4.3.2.1  
 REVISIONS:  
 RESIDENCE FOR MR & MRS ASHLEY